








GROUND FLOOR PLAN

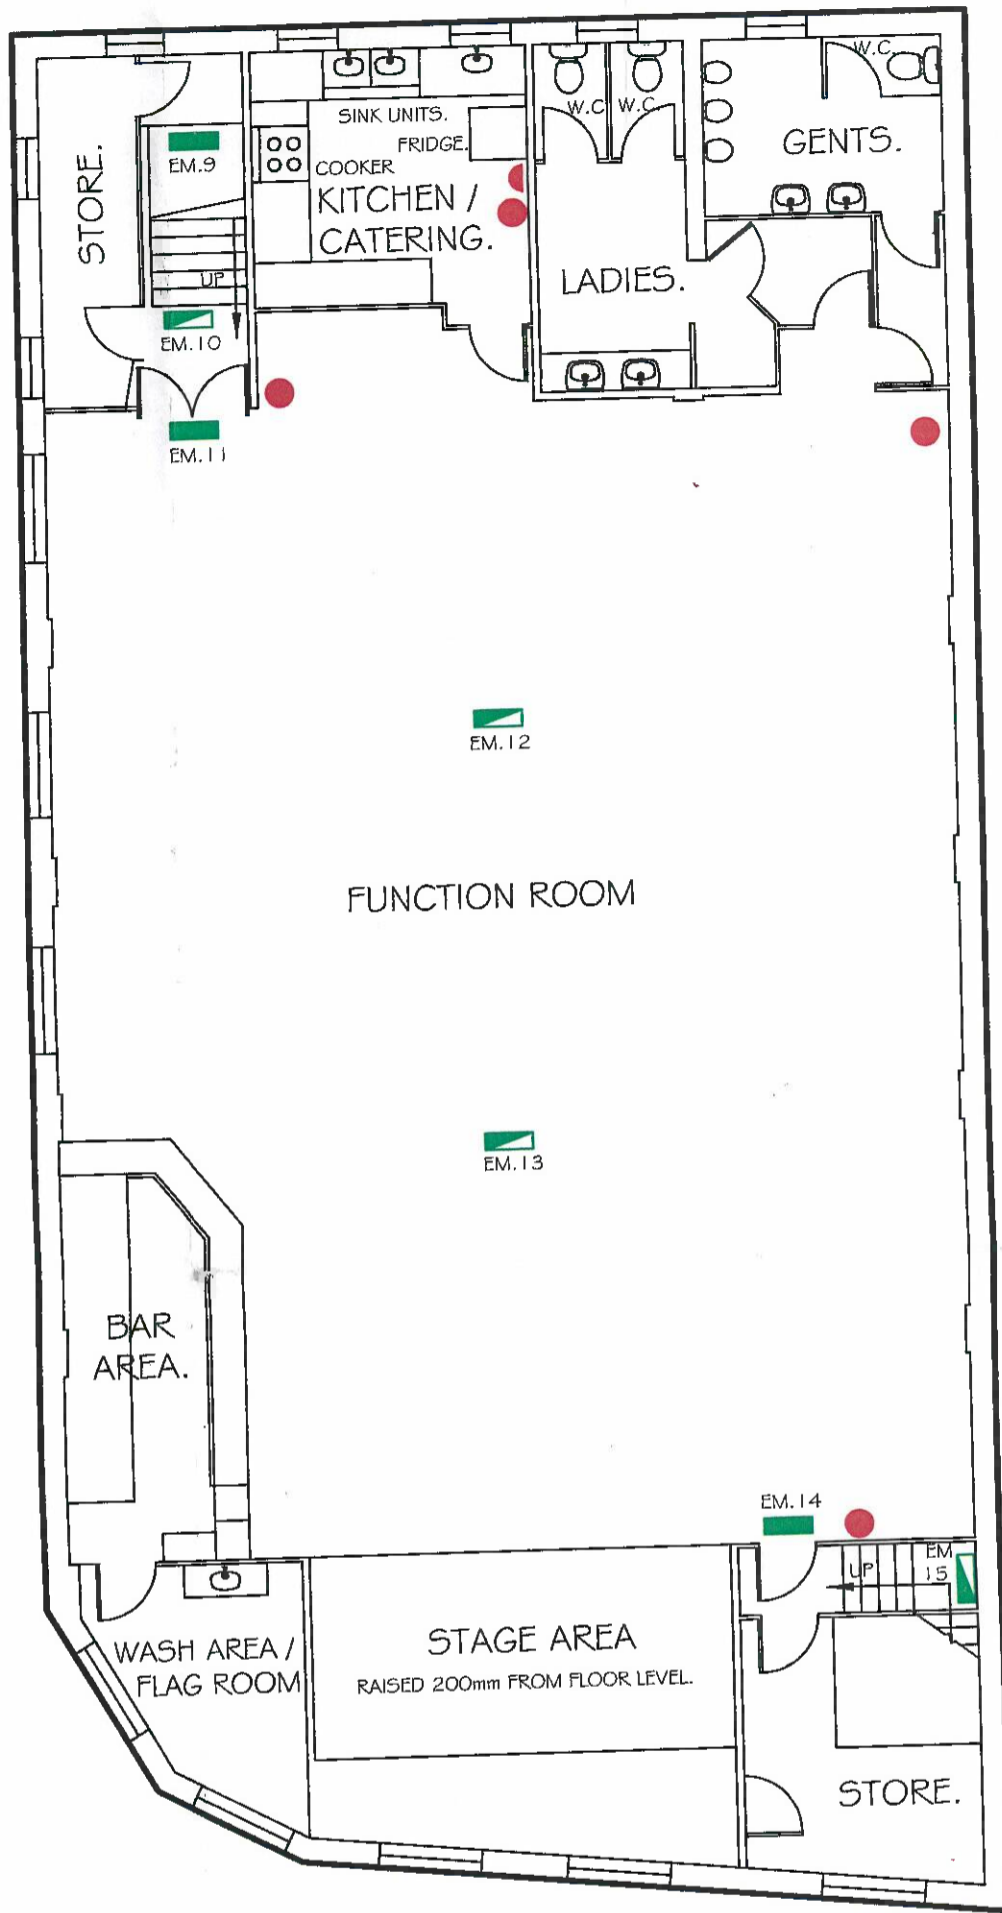

KEY TO SYMBOLS :

-  EMERGENCY EXIT SIGN
-  EMERGENCY LIGHT FIT
-  FIRE EXTINGUISHER.
-  EMERGENCY FIRE BLA
-  CCT MONITOR.
-  CCT CAMERA.

FIRST FLOOR PLAN

<p>THE INFORMATION ON THIS DRAWING IS CONFIDENTIAL TO AND SHALL NOT BE DISCLOSED TO A THIRD PARTY WITHOUT PRIOR WRITTEN PERMISSION.</p>	PROJECT		TITLE DENTC GROU	
	PROJECT No.	COST CENTRE		
	SCALE 1:100	DRAWN <i>P.A. Marshall</i>	DATE MAY-05	DRAWING N D
		CHECKED -	DATE -	
	APPROVED -	DATE -		